
 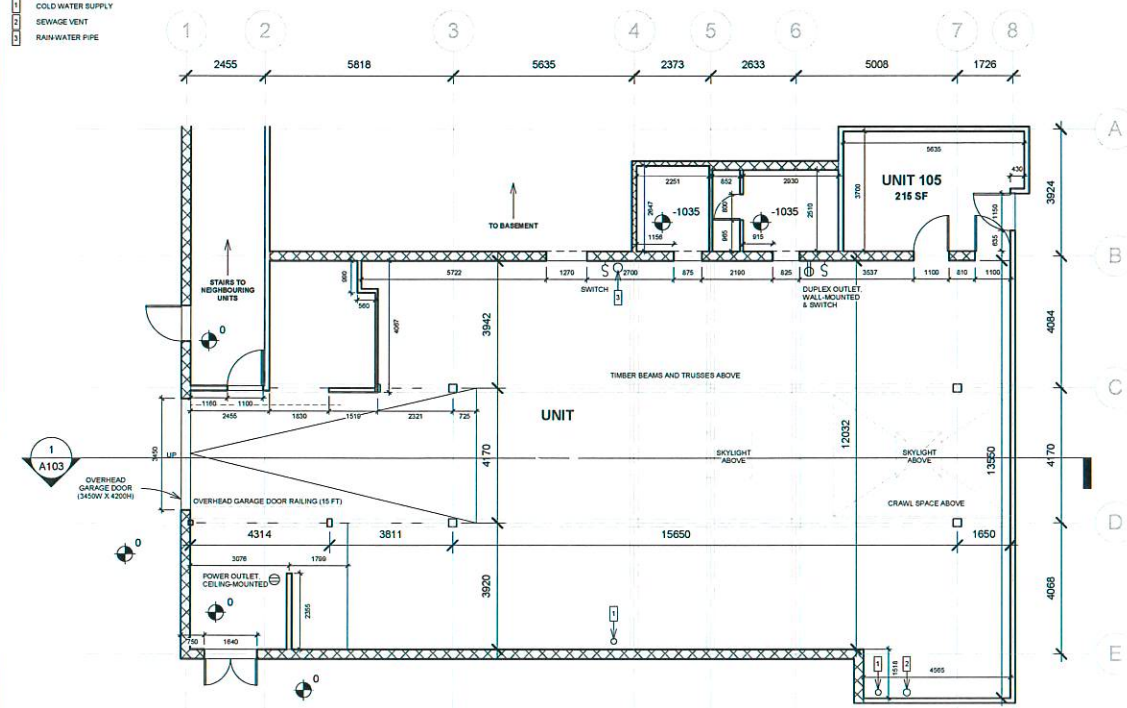


LEGEND

-  MASONRY WALL
-  COLD WATER SUPPLY
-  SEWAGE VENT
-  RAIN WATER PIPE




① Main Floor
1 : 100

DATE	DESCRIPTION
NOT FOR CONSTRUCTION	
NOT FOR CONSTRUCTION PURPOSES	
Consultants:	
<small>This drawing is the property of PROJECT CONSULTANTS LTD. and shall remain the property of the client. It is not to be used for any other project without the written consent of PROJECT CONSULTANTS LTD. The client shall be responsible for the accuracy of the information provided and the client shall indemnify and hold PROJECT CONSULTANTS LTD. harmless from all claims, damages, costs and expenses, including reasonable legal fees, arising from the use of this drawing.</small>	
	
Drawn Check Date Scale Project	Author Checker Approver 65 Jefferson
Drawing Title Floor Plan	
Check Scale (may be photo reduced)	
Sheet No. Drawing Number	01 A101


01/10/2014 10:38:05 PM




① Axo 01 - Short Section E

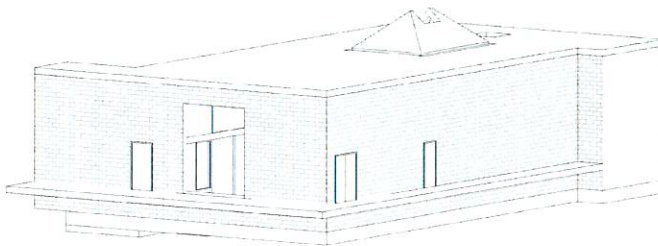

③ Axo 03 - Exterior

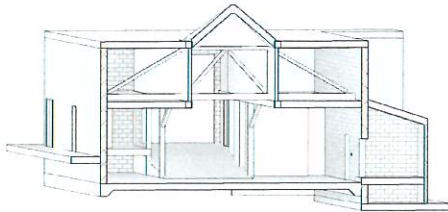


④ Axo 04 - Short Section W

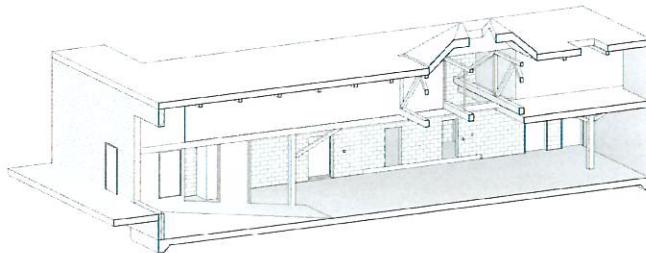

② Axo 02 - Long Section N

DATE	DESCRIPTION	#
NOT FOR CONSTRUCTION		
NOT FOR CONSTRUCTION PURPOSES		
Consultants:		
<small>This drawing is the property of BENTON & BOWLES INC. and is loaned to the client for their use only. It is not to be reproduced, stored in a retrieval system, or transmitted in any form or by any means, electronic, mechanical, photocopying, recording, or by any information storage and retrieval system, without the prior written permission of BENTON & BOWLES INC.</small>		

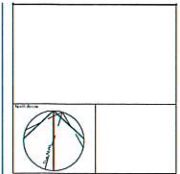

Author	_____
Checker	_____
Approver	_____
Client	_____
Project	65 Jefferson
Drawing Title	Asonometric Views
Check Scale (may be photo reduced)	1" = 1'-0"
Sheet Number	01
Drawing Number	A105

07/10/2014 4:38:13 PM